


CALL UTILITY NOTIFICATION
CENTER OF COLORADO
811
CALL 2 BUSINESS DAYS IN ADVANCE
BEFORE YOU DIG, GRADE OR EXCAVATE
FOR THE MARKING OF UNDERGROUND
MEMBER UTILITIES.

0 15 30 60
SCALE: 1" = 30'
ORIGINAL GRAPHIC SCALE

NOTE: ALL WATER, SANITARY SEWER AND STORM SEWER SHOWN ON THE PLANS ARE PRIVATE AND TO BE MAINTAINED BY THE PROPERTY HOA.

LEGEND

- SANITARY MANHOLE
- RIPRAP
- STORM INLET
- STORM FES
- STORM MANHOLE
- WATER FIRE HYDRANT
- WATER MANHOLE
- WATER VALVE
- WATER STOPBOX
- ELECTRIC BREAKER BOX
- ELECTRIC METER
- ELECTRIC MKR
- ELECTRIC PEDESTAL
- LIGHT POLE
- ELECTRIC VAULT
- TELEPHONE PEDESTAL
- FIBER OPTIC MKR
- FIBER OPTICS PEDESTAL
- GAS MKR POST
- IRRIGATION CONTROL BOX
- IRRIGATION VALVE
- VENT PIPE
- BUSH EVERGREEN
- BUSH DECIDUOUS
- TREE CONIFER
- TREE DECIDUOUS
- HANDICAP RAMP
- TRAFFIC CONTROL CABINET
- TRAFFIC CONTROL VAULT
- TRAFFIC SIGNAL
- DELINEATOR
- SIGN
- ELECTRIC UNDERGROUND
- TELEPHONE LINE UNDERGROUND
- FIBER OPTIC UNDERGROUND
- CABLE TV UNDERGROUND
- GAS LINE UNDERGROUND
- STORM REINFORCED CONCRETE PIPE
- WATER LINE UNDERGROUND
- SANITARY UNDERGROUND
- FENCE
- LANDSCAPE EDGE
- TREELINE
- CROWN ROAD
- EDGE ASPHALT
- EDGE CONCRETE
- TRAIL
- CHASE
- PAN FLOWLINE
- LINEMARKING WHITE STRIPE SOLID
- LINEMARKING YELLOW STRIPE SOLID
- GUARD RAIL
- SPEED BUMP
- STEPS
- STRUCTURE
- HANDRAIL
- WALL
- CONCRETE
- ASPHALT PAVEMENT

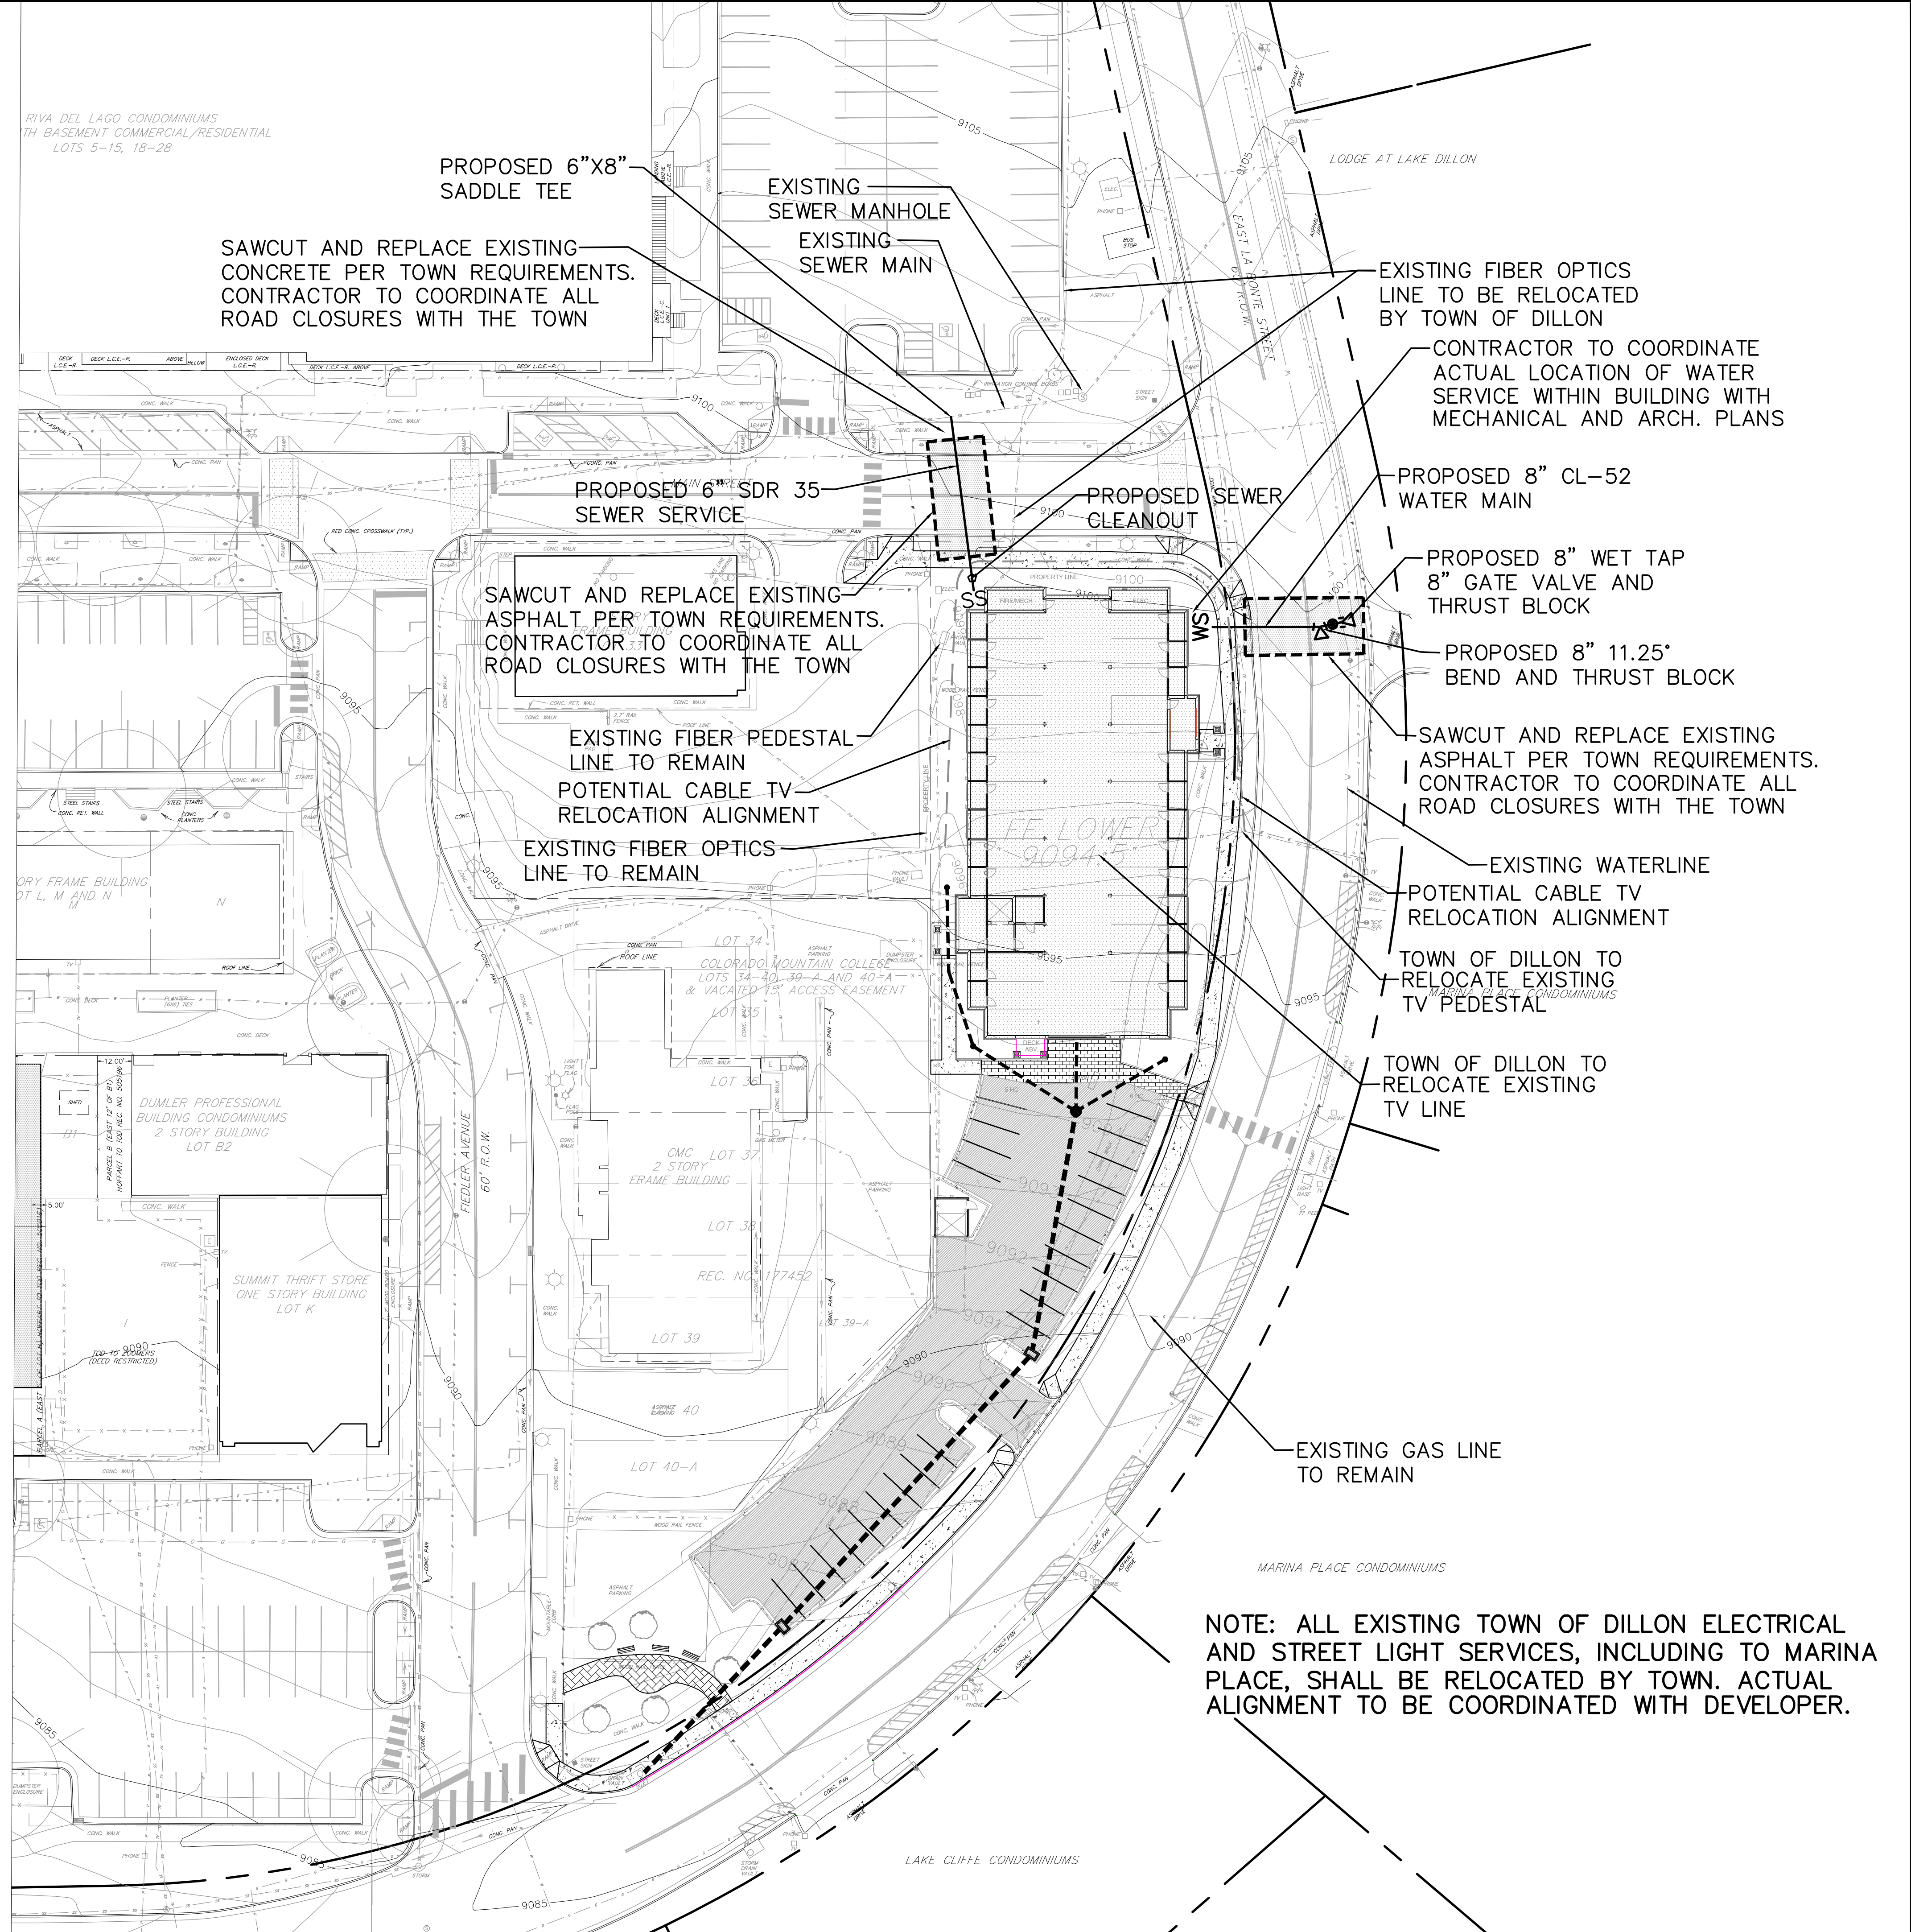

NOTE: ALL EXISTING TOWN OF DILLON ELECTRICAL AND STREET LIGHT SERVICES, INCLUDING TO MARINA PLACE, SHALL BE RELOCATED BY TOWN. ACTUAL ALIGNMENT TO BE COORDINATED WITH DEVELOPER.

REV. PER TOD	DATE	DESCRIPTION
2	7/25/17	REVISED PER TOD COMMENTS
1	7/7/17	TOD FINAL SITE PLAN & PLAT SUBMITTAL
No.		

TEN MILE ENGINEERING, INC.
Professional Civil Engineers
Po Box 1785
Frisco, CO 80443
970.485.5773
tenmileengineer@aol.com

DILLON FLATS
LOTS 17A & 17B
TOWN OF DILLON, COLORADO
OVERALL UTILITY PLAN

Project DILLON FLATS	
Date 7/7/17	Sheet 9
Scale 1"=30'	